


ASPHALT CONTRACTORS GRAVEL PIT

SITE IMPROVEMENT PLANS
SEPTEMBER 08, 2020

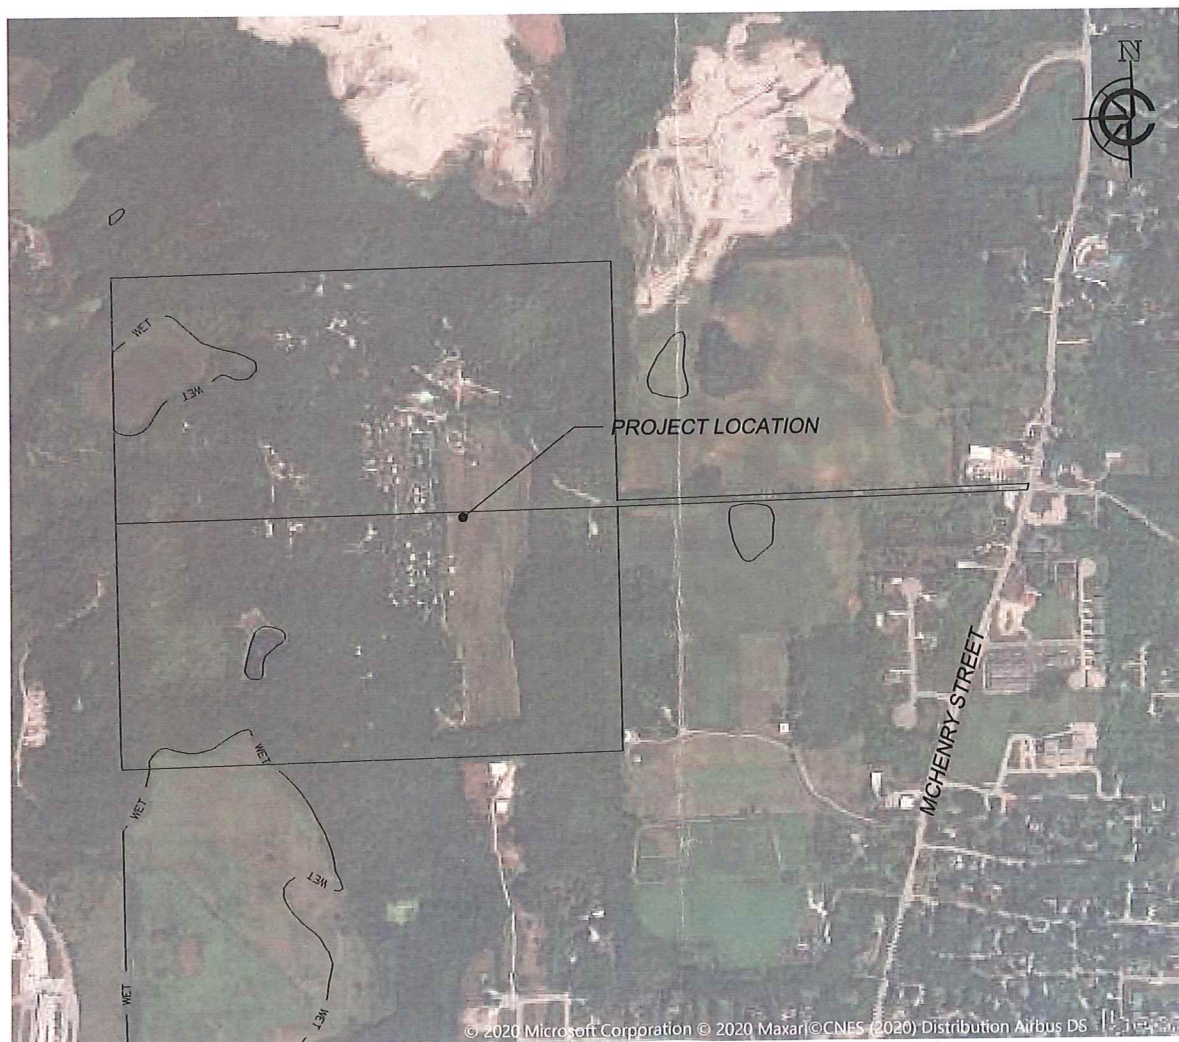

CIVIL DRAWING INDEX	
1 OF 13	TITLE SHEET
2-4 OF 13	EXISTING CONDITIONS PLAN
5-6 OF 13	OVERALL SITE PLAN
7 OF 13	PHASING PLAN
8-10 OF 13	GRADING PLAN
11-13 OF 13	CROSS SECTIONS

ALL SPECIFICATIONS ARE REFERENCED TO THE WISCONSIN DEPARTMENT OF TRANSPORTATION STANDARD SPECIFICATIONS, LATEST EDITION.
DETAILS UNDER CARDINAL ENGINEERING LLC TITLE BLOCK TAKE PRECEDENCE.
ALL SPECIFICATIONS FOR STANDARD SEWER AND WATER CONSTRUCTION IN WISCONSIN SHALL ALSO BE FOLLOWED, IF NOT DIRECTLY REFERENCED UNDER THIS TITLE BLOCK.

CONTACT INFORMATION:

OWNER: ASPHALT CONTRACTORS INC
1701 MAIN STREET
UNION GROVE, WI 53182
PHONE: 262-717-8350

ENGINEER: RYAN CARDINAL, P.E.
CARDINAL ENGINEERING, LLC
1200 LA SALLE STREET,
LAKE GENEVA, WI 53147
PHONE: 262-757-8776

CLIENT

ASPHALT CONTRACTORS GRAVEL PIT
TOWN OF BURLINGTON, RACINE COUNTY, WI

TITLE

PRELIMINARY



CARDINAL ENGINEERING LLC
DESIGNING IN TRUE DIRECTIONS

1200 LA SALLE STREET,
LAKE GENEVA, WI 53147
262-757-8776
CARDINALENGINEERINGWI.COM

RECEIVED
OCT 13 2020
RACINE COUNTY

NO.	REVISION DESCRIPTION	REV DATE

SCALE	1" = 50'
PROJECT NUMBER	20388
DATE	09/08/2020
PROJECT MGR	RYAN CARDINAL, PE
DRAWN BY	BDP
DESIGNED BY	BDP

SHEET NUMBER

1 OF 13


NOT FOR CONSTRUCTION

DIGGERS HOTLINE

Dial 811 or (800)242-8511

www.DiggersHotline.com

CARDINAL ENGINEERING LLC ASSUMES NO
RESPONSIBILITY FOR DAMAGES, LIABILITY OR COSTS
RESULTING FROM CHANGES OR ALTERATIONS MADE
TO THIS PLAN WITHOUT THE EXPRESSED WRITTEN
CONSENT OF CARDINAL ENGINEERING LLC.

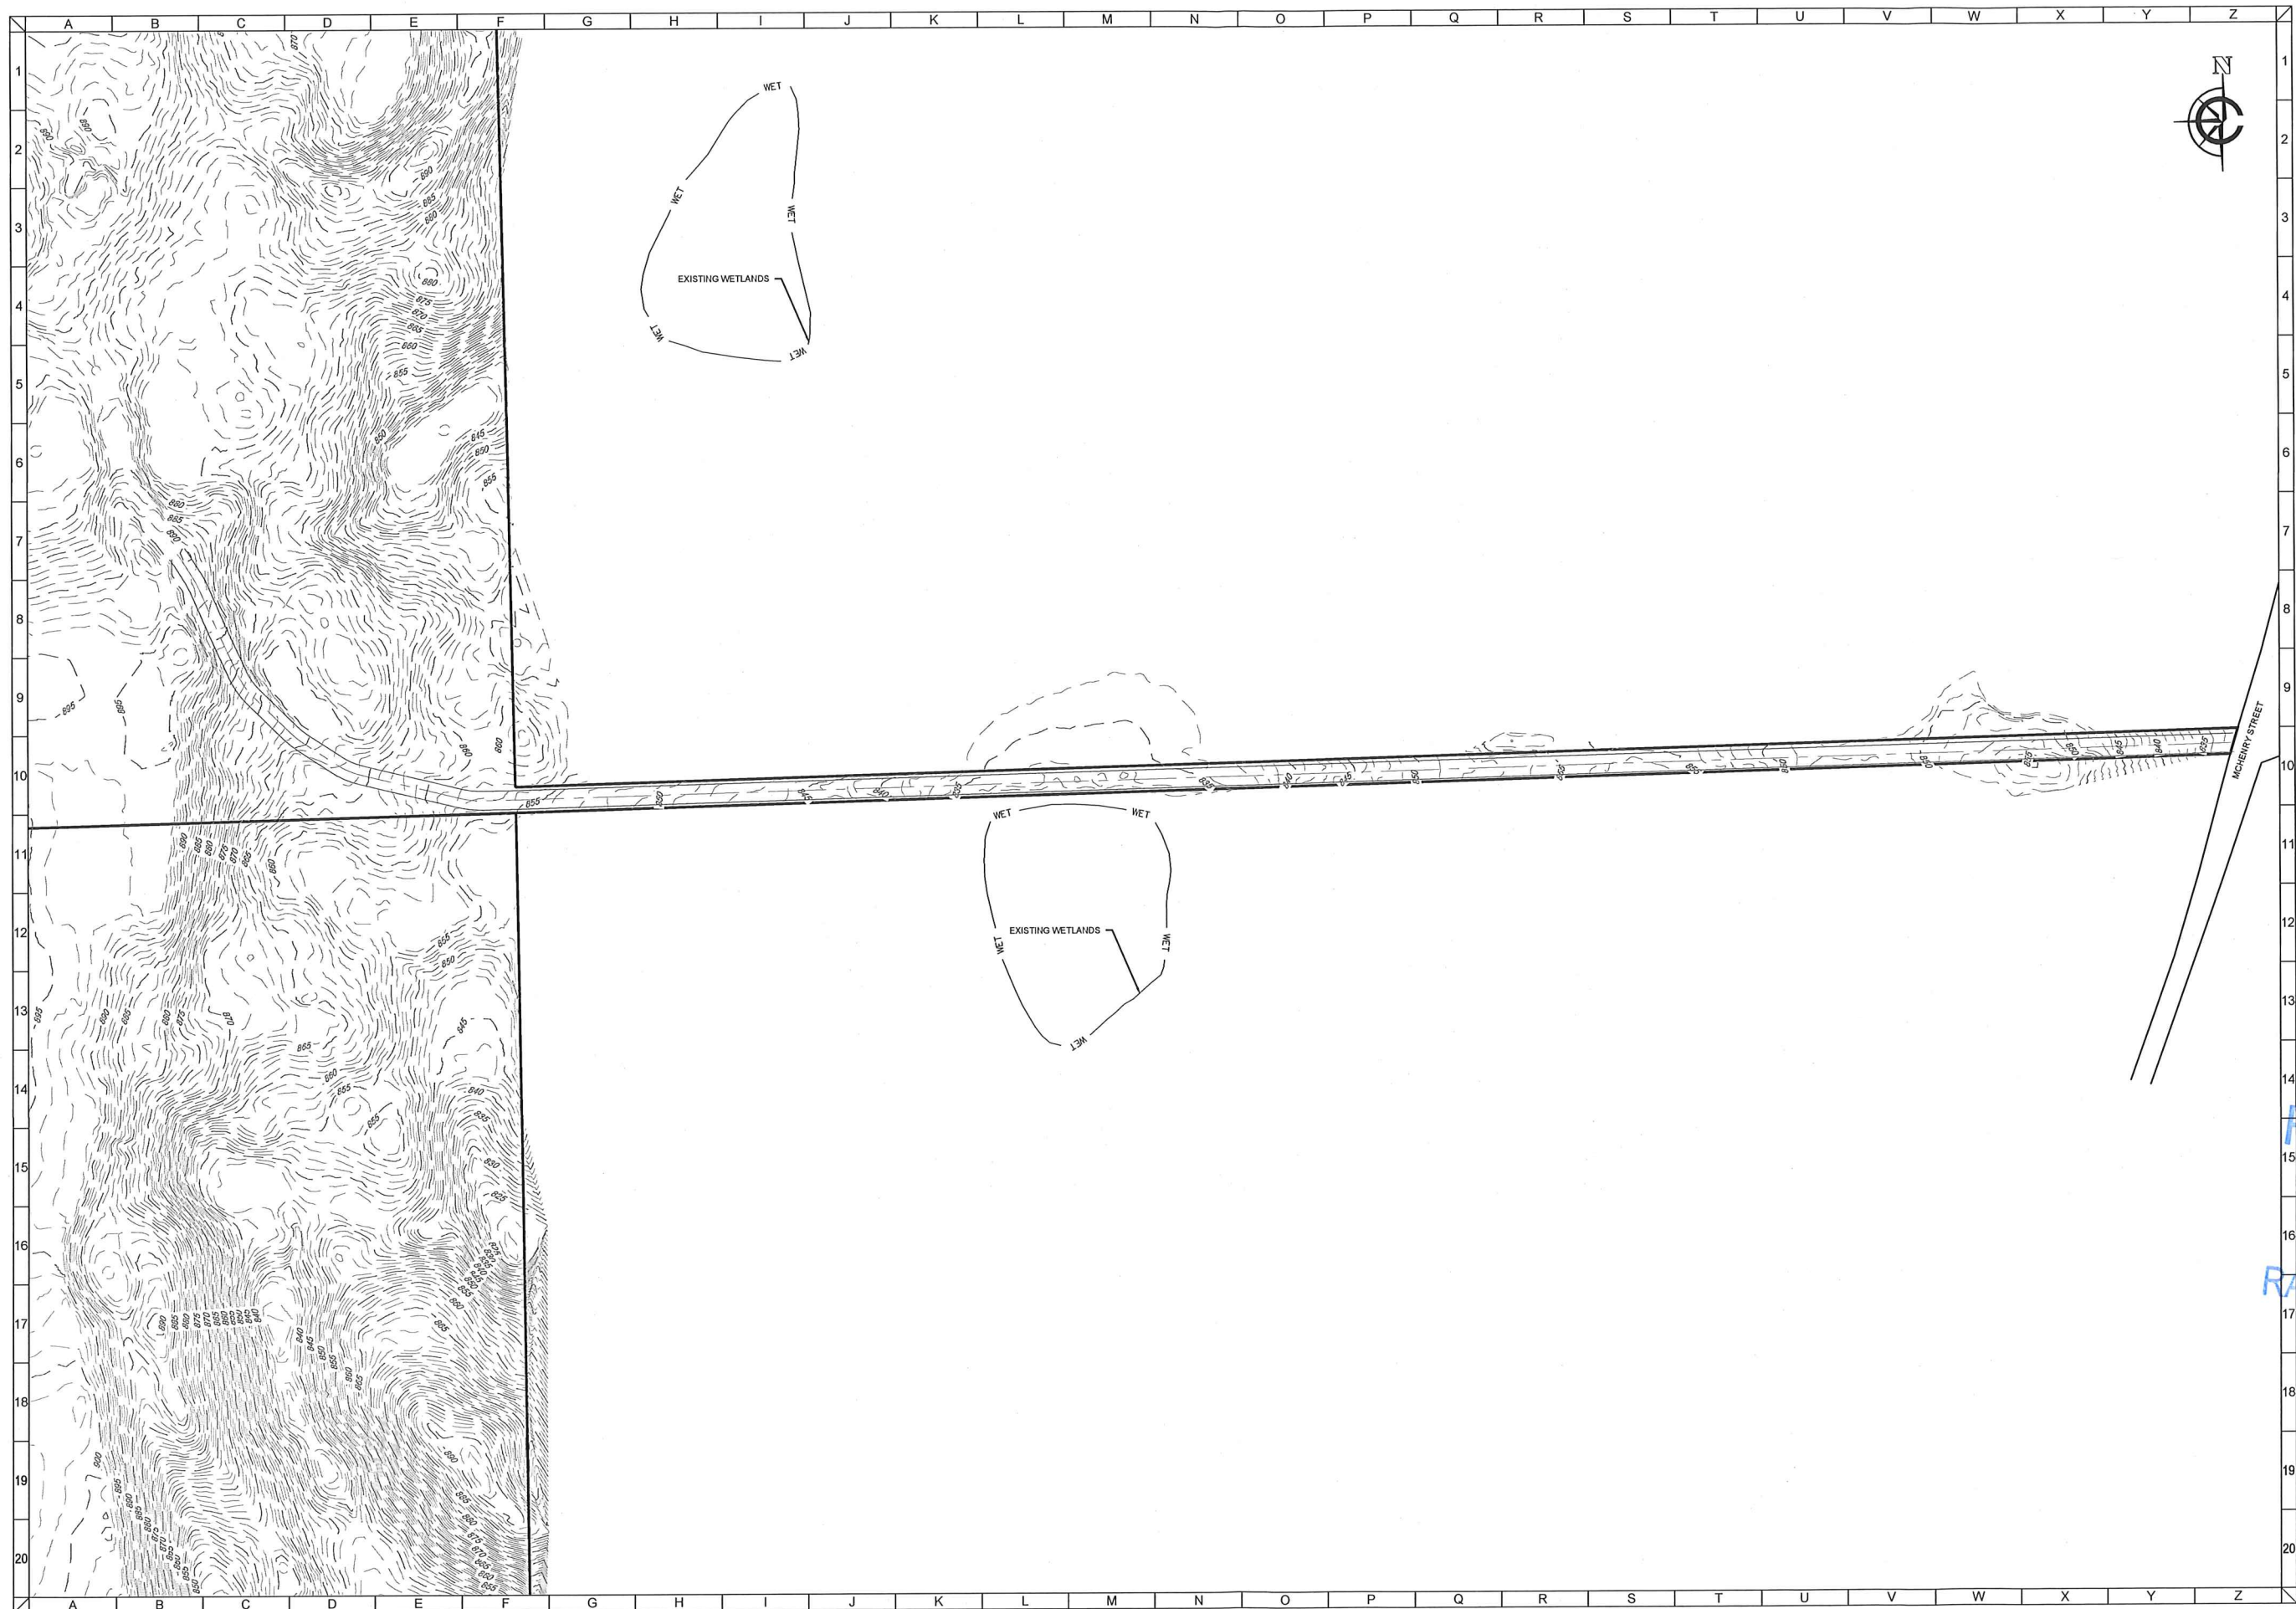


CLIENT

ASPHALT CONTRACTORS GRAVEL PIT
TOWN OF BURLINGTON, RACINE COUNTY, WI

EXISTING CONDITIONS

EXHIBIT

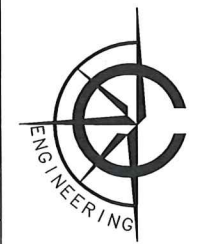

CARDINAL ENGINEERING LLC
DESIGNING IN TRUE DIRECTIONS

1200 LA SALLE STREET,
LAKE GENEVA, WI 53147
262-757-4778
CARDINALENGINEERINGWI.COM

RECEIVED
OCT 13 2020
RACINE COUNTY

NO.	REVISION DESCRIPTION	REV DATE

SCALE 1" = 100'

PROJECT NUMBER 20388

DATE 09/08/2020

PROJECT MGR RYAN CARDINAL, PE

DRAWN BY BDP

DESIGNED BY BDP

SHEET NUMBER
4 OF 13




CLIENT

ASPHALT CONTRACTORS GRAVEL PIT

TOWN OF BURLINGTON, RACINE COUNTY, WI

EXHIBIT

SITE PLAN

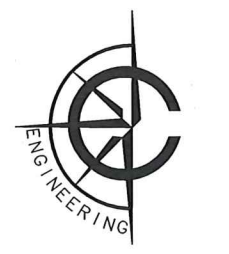

CARDINAL ENGINEERING LLC
DESIGNING IN TRUE DIRECTIONS

1200 LA SALLE STREET,
LAKE GENEVA, WI 53147
262-757-8776
CARDINALENGINEERING.COM

RECEIVED

OCT 13 2020

RACINE COUNTY

NO.	REVISION DESCRIPTION	REV DATE

SCALE 1" = 200'

PROJECT NUMBER 20388

DATE 06/19/2020

PROJECT MGR RYAN CARDINAL, PE

DRAWN BY BDP

DESIGNED BY BDP

SHEET NUMBER

5 OF 13